


SCALE: 1" = 50'


# PLAN

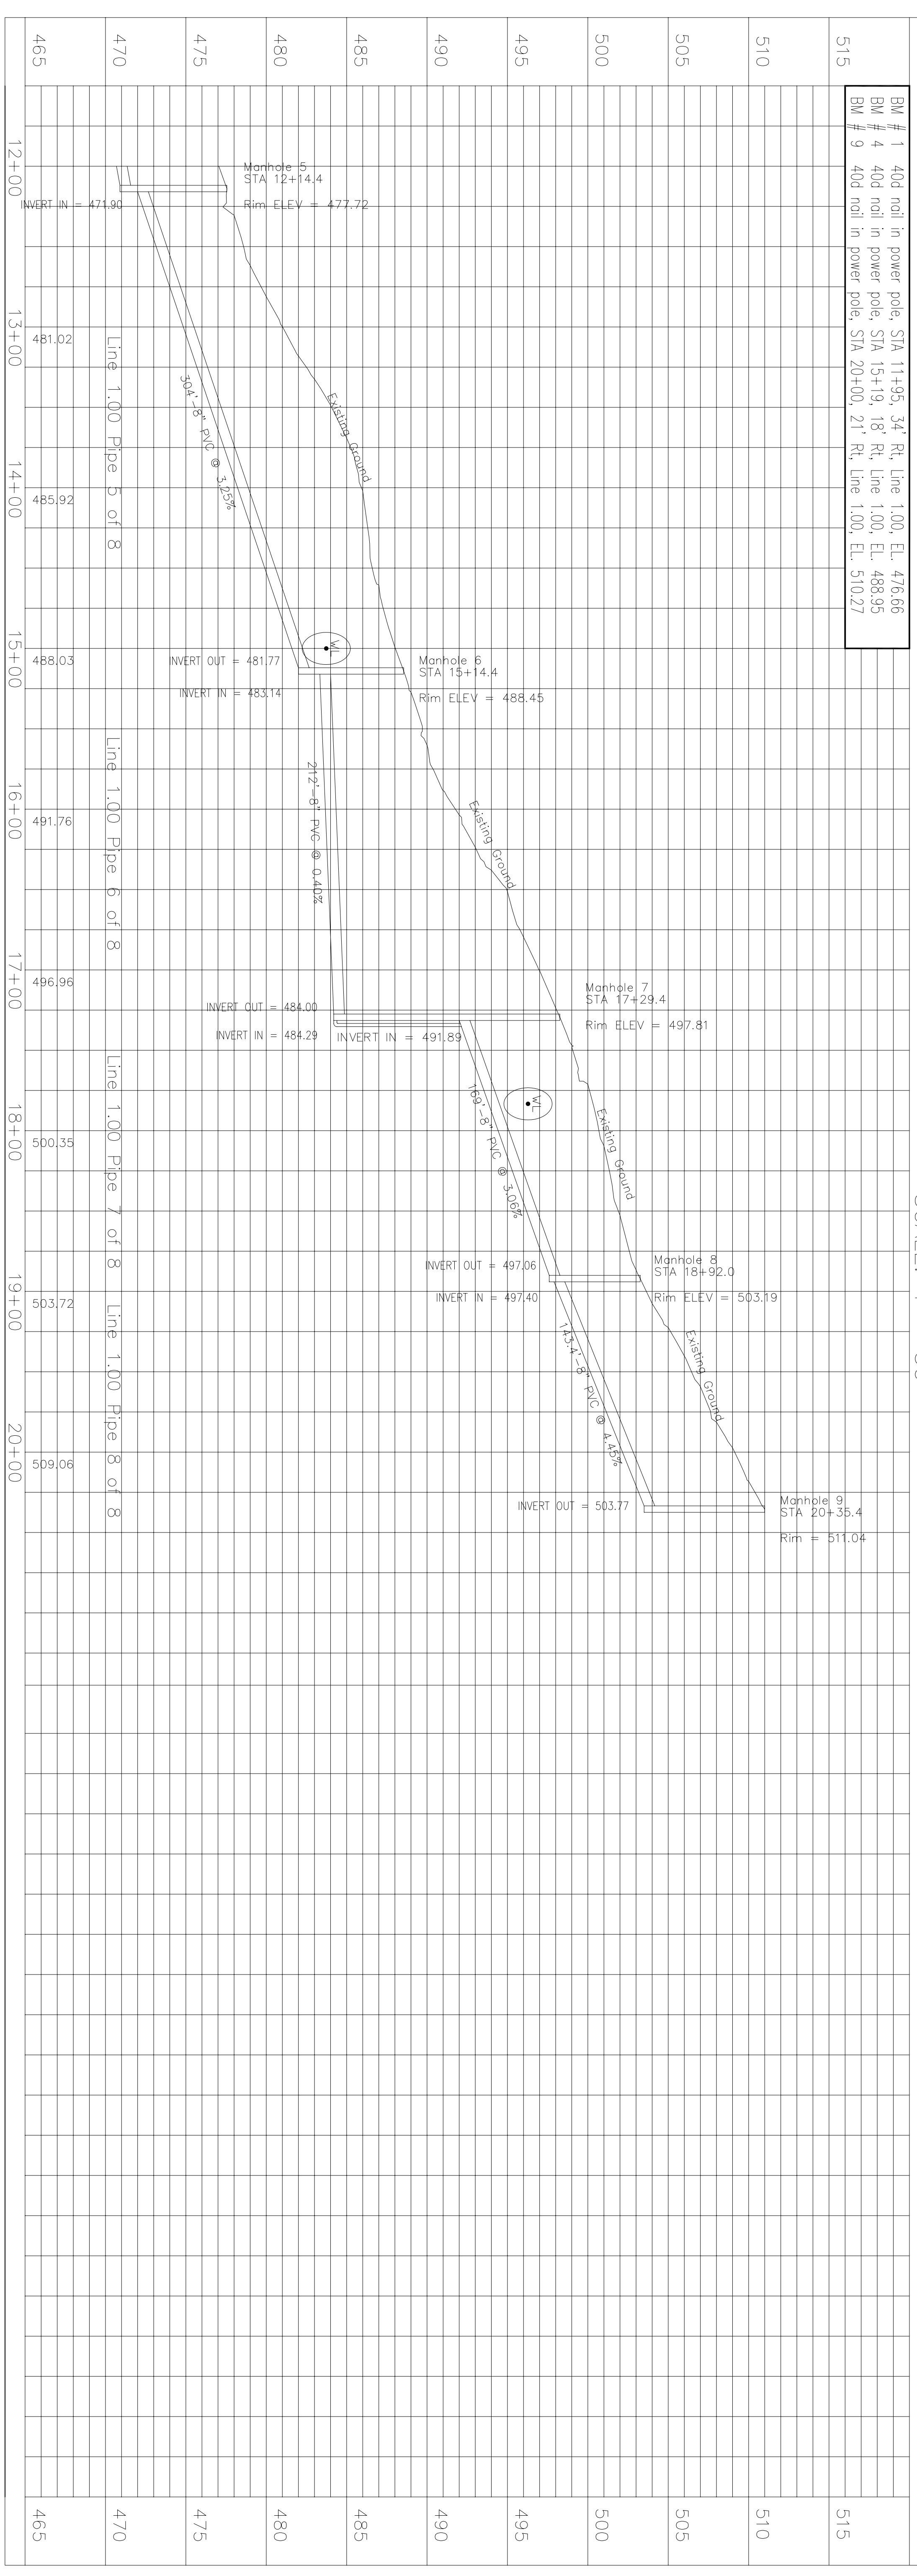

# PROFILE

SCALE: Ver 1" = 5' Horiz 1" = 50'

LEGEND:

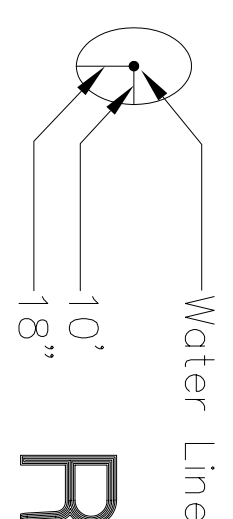

# RECORD DOCUMENT

7/98

### NOTES

1. ANY SEPTIC LEACH FIELD LINES CUT DURING CONSTRUCTION OF NEW SANITARY SEWER LINE SHALL BE RECONNECTED AT CONTRACTOR'S EXPENSE
2. ALL STREETS HAVE 60' RIGHT OF WAY UNLESS OTHERWISE NOTED
3. SOIL BORING INFORMATION IS AVAILABLE FOR REVIEW AT ENGINEER'S OFFICE

### UTILITY NOTES

CONTRACTOR TO NOTIFY INDIANA UNDERGROUND PLANT PROTECTION CENTER (HOLEY MOLE, INC.) @ 1-800-382-5544, MINIMUM 2 WORKING DAYS PRIOR TO THE START OF CONSTRUCTION AND REQUEST ALL UNDERGROUND UTILITIES BE MARKED

CALL ONLY ALERTS MEMBER UTILITIES. CONTRACTOR RESPONSIBLE FOR CONTACTING NON-MEMBER UTILITIES.

UTILITY COLOR CODES:

- RED - ELECTRIC
- YELLOW - GAS, OIL, PETROLEUM PRODUCTS
- ORANGE - COMMUNICATIONS, TELEPHONE, CATV,
- BLUE - WATER
- GREEN - FIBER OPTICS & TRAFFIC SIGNALS
- WHITE - SEWER

THE LOCATIONS OF UNDERGROUND UTILITIES AS SHOWN HEREIN HAVE BEEN DETERMINED FROM INFORMATION PROVIDED BY OTHERS. NEITHER THE OWNER NOR ENGINEER ASSUME RESPONSIBILITY FOR THE ACCURACY OF INFORMATION PROVIDED BY OTHERS

SEE APPENDIX OF SPECIFICATIONS FOR STANDARD DETAILS

SANITARY SEWER LINES TO BE LOCATED NO CLOSER THAN 10 FEET HORIZONTAL AND 1.5 FEET VERTICAL FROM WATER LINES.

Plan and Profile  
Line 1.00

Florence Regional Sewer District  
Florence, Indiana

SHEET NUMBER  
**3**

JOB NO	DATE	DESCRIPTION	BY	DATE
193-2453	6/96	REVISED LINE LOCATIONS	JCE	6/96
DWN.BY	JCE			
CHK.BY	JJG			
DATE	1/96			
SCALE	As Noted			

HOWARD J. BARTH & ASSOCIATES, INC.  
**CONSULTING ENGINEERS**

347 E. WASHINGTON STREET  
GREENSBURG, INDIANA 47240  
812-663-2177 FAX 812/663-7906

