

SCALE: 1" = 50'


- NOTES**
1. ANY SEPTIC LEACH FIELD LINES CUT DURING CONSTRUCTION OF NEW SANITARY SEWER LINE SHALL BE RECONNECTED AT CONTRACTOR'S EXPENSE
  2. ALL STREETS HAVE 60' RIGHT OF WAY UNLESS OTHERWISE NOTED
  3. SOIL BORING INFORMATION IS AVAILABLE FOR REVIEW AT ENGINEER'S OFFICE

- UTILITY NOTES**
- CONTRACTOR TO NOTIFY INDIANA UNDERGROUND PLANT PROTECTION CENTER (\"HOLEY MOLEY\") @ 1-800-392-5544 MINIMUM 2 WORKING DAYS PRIOR TO THE START OF CONSTRUCTION AND REQUEST ALL UNDERGROUND UTILITIES BE MARKED
- CALL ONLY ALERTS MEMBER UTILITIES. CONTRACTOR RESPONSIBLE FOR CONTACTING NON-MEMBER UTILITIES.
- UTILITY COLOR CODES:
- RED - ELECTRIC
  - YELLOW - GAS, OIL, PETROLEUM PRODUCTS
  - ORANGE - COMMUNICATIONS, TELEPHONE, CATV,
  - BLUE - WATER
  - GREEN - FIBER OPTICS & TRAFFIC SIGNALS
  - WHITE - PROPOSED EXCAVATION

THE LOCATIONS OF UNDERGROUND UTILITIES AS SHOWN HEREIN HAVE BEEN DETERMINED FROM INFORMATION PROVIDED BY OTHERS. FOR NEITHER THE OWNER NOR ENGINEER ASSUME RESPONSIBILITY FOR THE ACCURACY OF INFORMATION PROVIDED BY OTHERS

SEE APPENDIX OF SPECIFICATIONS FOR STANDARD DETAILS


SANITARY SEWER LINES TO BE LOCATED NO CLOSER THAN 10 FEET HORIZONTAL AND 1.5 FEET VERTICAL FROM WATER LINES.

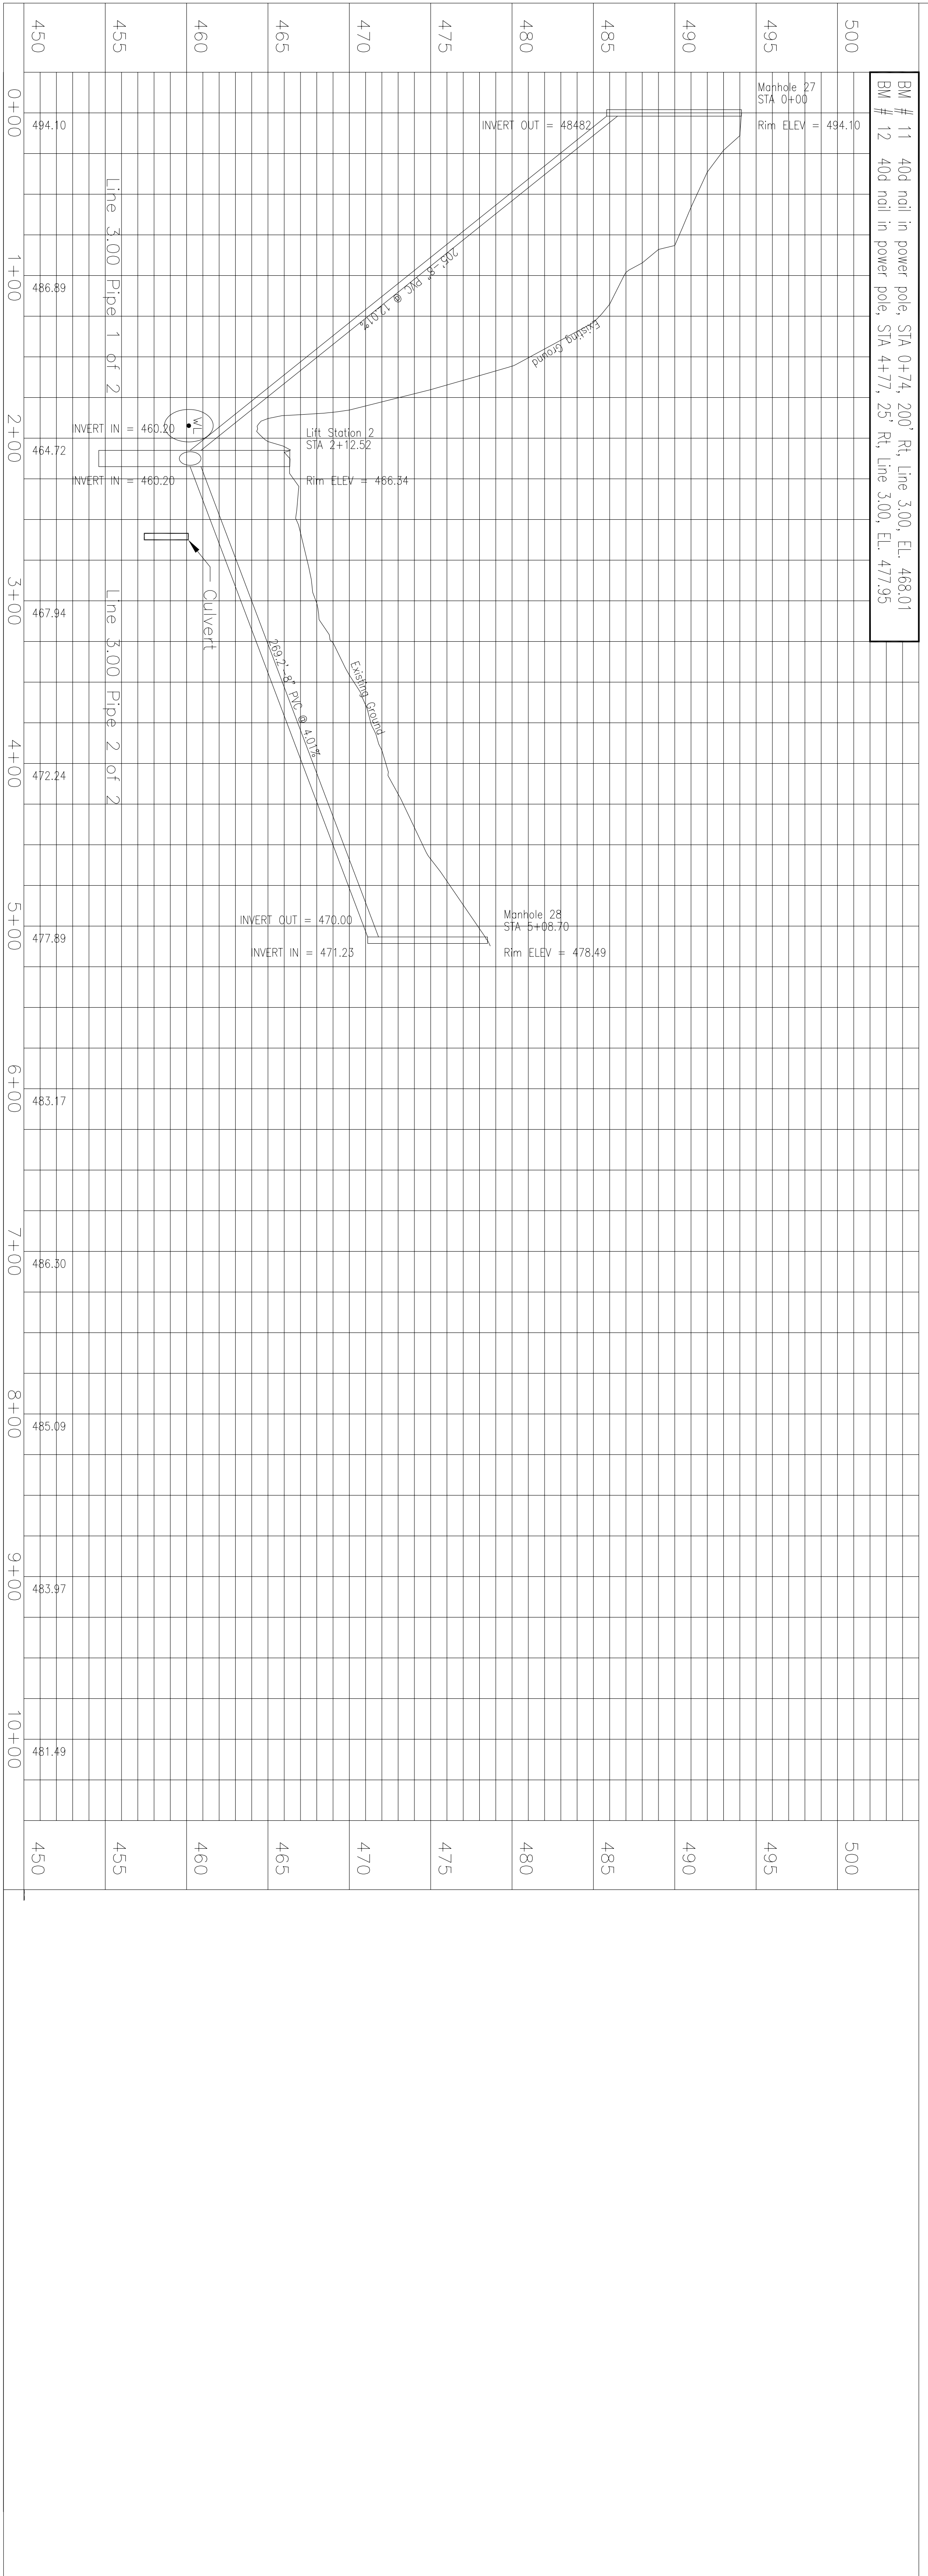

**PROFILE**

SCALE: Ver 1" = 5' Horiz 1" = 50'

LEGEND:

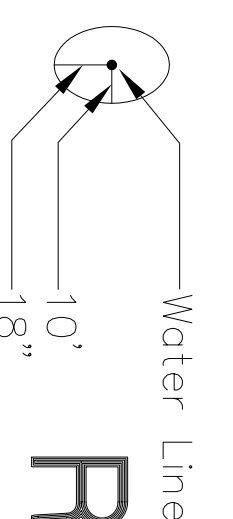

**RECORD DOCUMENT**  
7/98

Plan and Profile  
Line 3.00  
Florence Regional Sewer District  
Florence, Indiana

JOB NO	193-2453	JCE	4/2/96
DWN BY	JCE		
CHK BY	JJG		
DATE	2/96		
SCALE	As Noted		
NO	DESCRIPTION	BY	DATE
1	PIPE SLOPE CHANGED, LIFT STATION & FORCE MAIN NOTE		

HOWARD J. BARTH & ASSOCIATES, INC.  
**CONSULTING ENGINEERS**  
347 E. WASHINGTON STREET  
GREENSBURG, INDIANA 47240  
812-663-2177 FAX 812/663-7906

© copyright 1996

SHEET NUMBER  
**9**