



# PLAN

SCALE: 1" = 50'

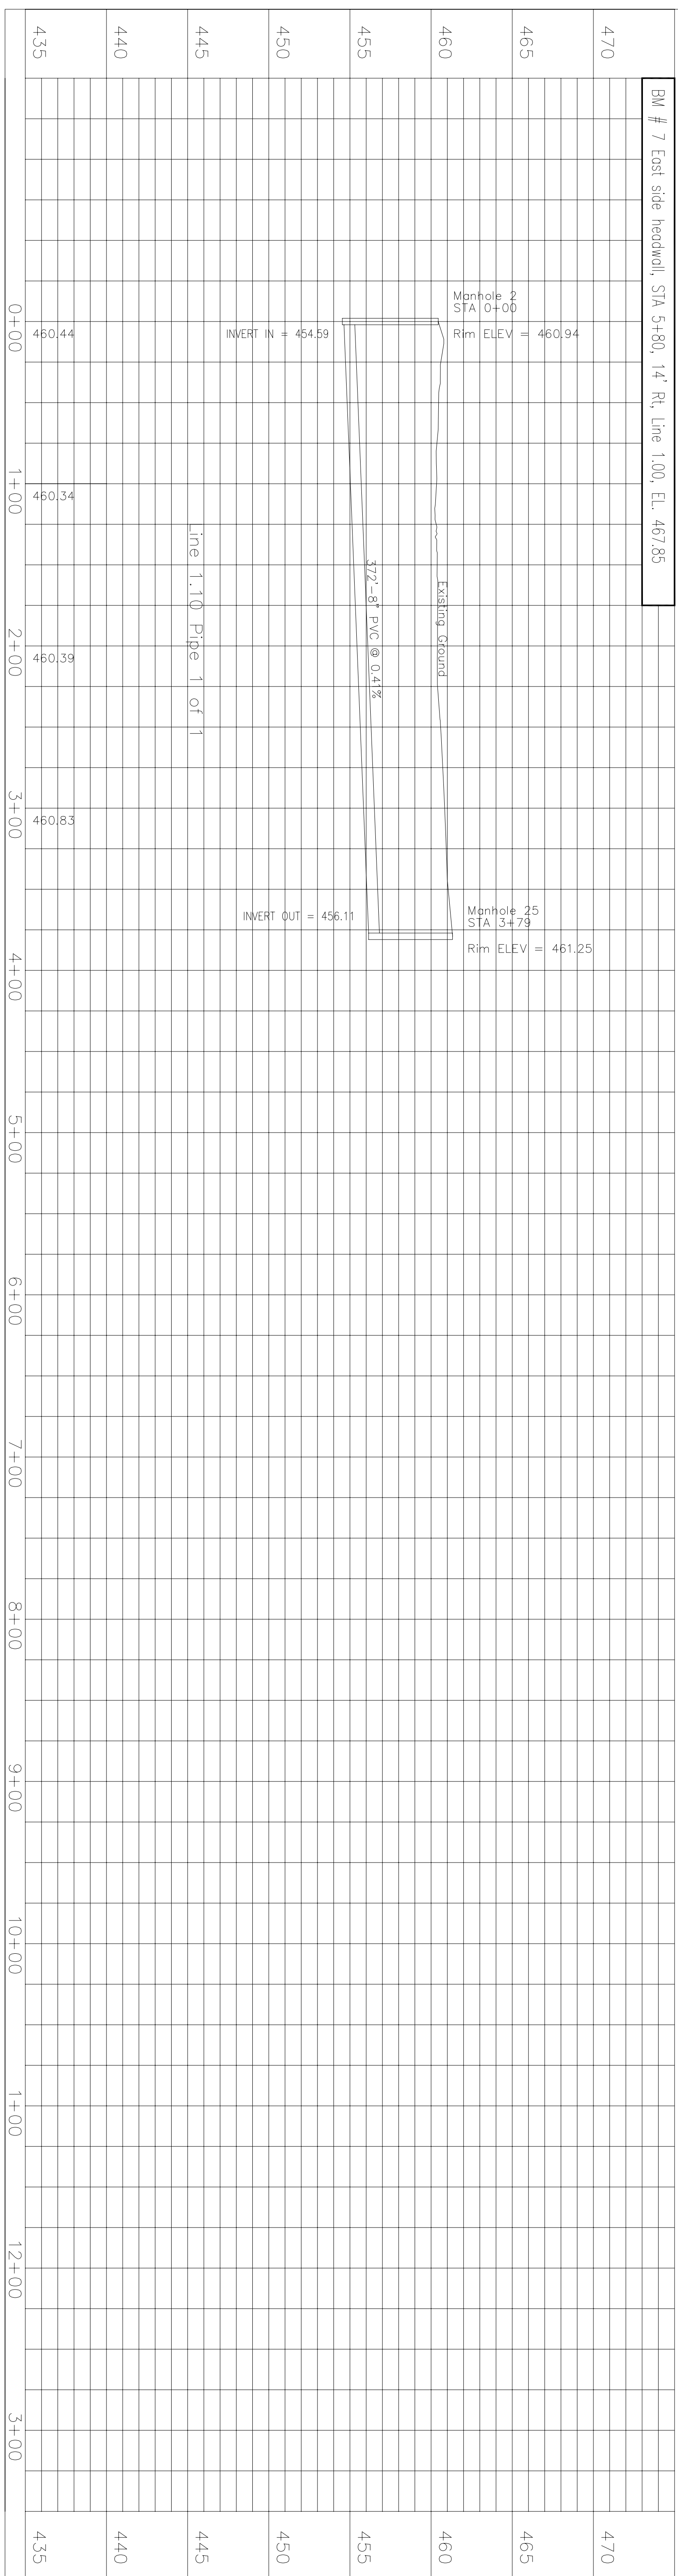

# PROFILE

SCALE: Ver 1" = 5' Horz 1" = 50'

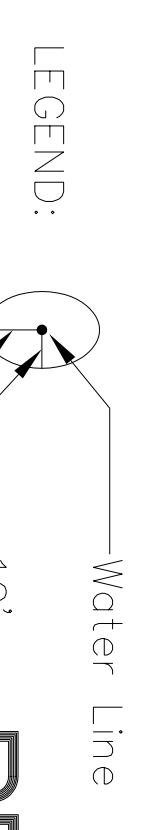

# RECORD DOCUMENT

7/98

### NOTES

1. ANY SEPTIC LEACH FIELD LINES CUT DURING CONSTRUCTION OF NEW SANITARY SEWER LINE SHALL BE RECONNECTED AT CONTRACTOR'S EXPENSE
2. ALL STREETS HAVE 60' RIGHT OF WAY UNLESS OTHERWISE NOTED
3. SOIL BORING INFORMATION IS AVAILABLE FOR REVIEW AT ENGINEER'S OFFICE

### UTILITY NOTES

CONTRACTOR TO NOTIFY INDIANA UNDERGROUND PLANT PROTECTION CENTER ("HOLEY MOLEY") @ 1-800-382-5544, MINIMUM 2 WORKING DAYS PRIOR TO THE START OF CONSTRUCTION AND REQUEST ALL UNDERGROUND UTILITIES BE MARKED

CALL ONLY ALERTS MEMBER UTILITIES. CONTRACTOR RESPONSIBLE FOR CONTACTING NON-MEMBER UTILITIES.

UTILITY COLOR CODES:

- RED - ELECTRIC
- YELLOW - GAS, OIL, PETROLEUM PRODUCTS
- GREEN - TELEPHONE
- ORANGE - FIBER OPTICS & TRAFFIC SIGNALS
- BLUE - WATER
- GREEN - SEWER
- WHITE - PROPOSED EXCAVATION

THE LOCATIONS OF UNDERGROUND UTILITIES AS SHOWN HEREIN HAVE BEEN OBTAINED FROM AVAILABLE RECORDS AND FIELD SURVEY. NEITHER THE OWNER NOR ENGINEER ASSUME RESPONSIBILITY FOR THE ACCURACY OF INFORMATION PROVIDED BY OTHERS

SEE APPENDIX OF SPECIFICATIONS FOR STANDARD DETAILS

SANITARY SEWER LINES TO BE LOCATED NO CLOSER THAN 10 FEET HORIZONTAL AND 1.5 FEET VERTICAL FROM WATER LINES.

Plan and Profile  
Line 1.10

Florence Regional Sewer District  
Florence, Indiana

SHEET NUMBER  
4

JOB NO	193-2453	DESCRIPTION	BY	DATE
DWN BY	JCE	REVISIONS		
CHK BY	JJG			
DATE	1/96			
SCALE	As Noted			

HOWARD J. BARTH & ASSOCIATES, INC.

**CONSULTING ENGINEERS**

347 E. WASHINGTON STREET  
GREENSBURG, INDIANA 47240  
812-663-2177 FAX 812/663-7906

© copyright 1996

