


SCALE: 1" = 50'

PLAN

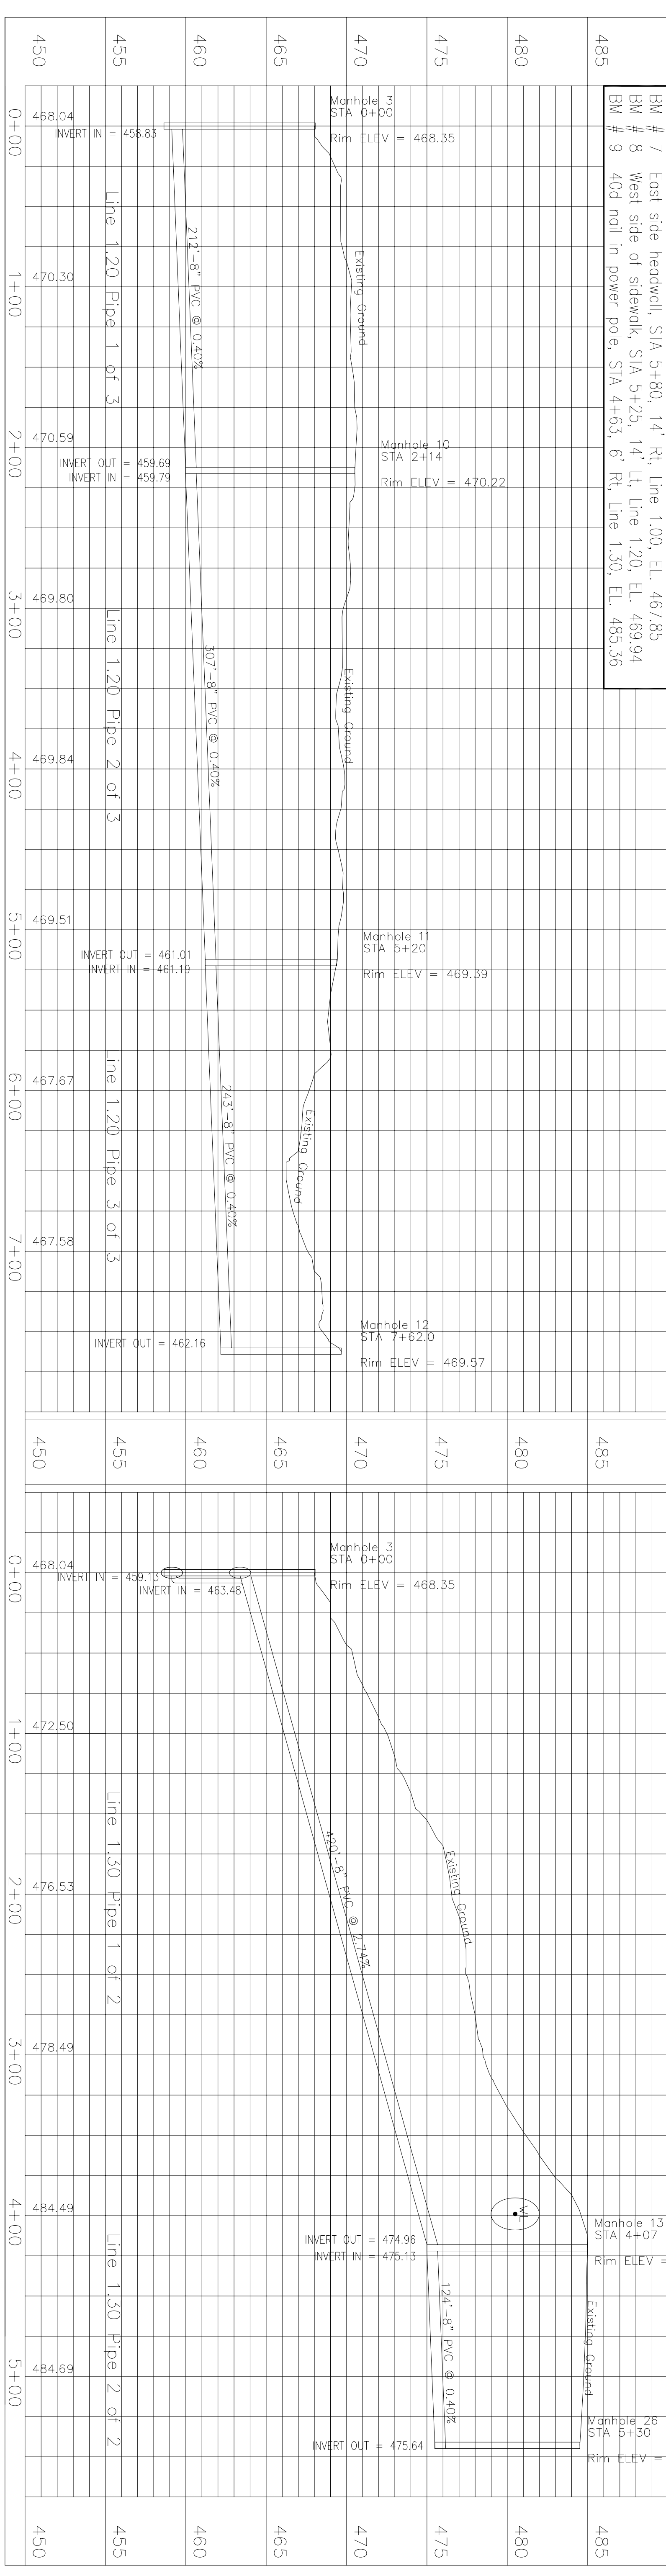

PROFILE

SCALE: Ver 1" = 5' Horiz 1" = 50'

- NOTES**
1. ANY SEPTIC LEACH FIELD LINES CUT DURING CONSTRUCTION OF NEW SANITARY SEWER LINE SHALL BE RECONNECTED AT CONTRACTOR'S EXPENSE
 2. ALL STREETS HAVE 60' RIGHT OF WAY UNLESS OTHERWISE NOTED
 3. SOIL BORING INFORMATION IS AVAILABLE FOR REVIEW AT ENGINEER'S OFFICE

UTILITY NOTES

CONTRACTOR TO NOTIFY INDIANA UNDERGROUND PLANT PROTECTION CENTER ("HOLEY MOLEY") @ 1-800-382-5544, MINIMUM 2 WORKING DAYS PRIOR TO THE START OF CONSTRUCTION AND REQUEST ALL UNDERGROUND UTILITIES BE MARKED

CALL ONLY ALERTS MEMBER UTILITIES. CONTRACTOR RESPONSIBLE FOR CONTACTING NON-MEMBER UTILITIES.


UTILITY COLOR CODES:

- RED - ELECTRIC
- YELLOW - GAS, OIL, PETROLEUM PRODUCTS
- GREEN - TELEPHONE
- ORANGE - FIBER OPTICS & TRAFFIC SIGNALS
- BLUE - WATER
- GREEN - SEWER
- WHITE - PROPOSED EXCAVATION

THE LOCATIONS OF UNDERGROUND UTILITIES AS SHOWN HEREIN HAVE BEEN OBTAINED FROM RECORD DRAWINGS AND FIELD SURVEYS. NEITHER THE OWNER NOR ENGINEER ASSUME RESPONSIBILITY FOR THE ACCURACY OF INFORMATION PROVIDED BY OTHERS

SEE APPENDIX OF SPECIFICATIONS FOR STANDARD DETAILS

SANITARY SEWER LINES TO BE LOCATED NO CLOSER THAN 10 FEET HORIZONTAL AND 1.5 FEET VERTICAL FROM WATER LINES.

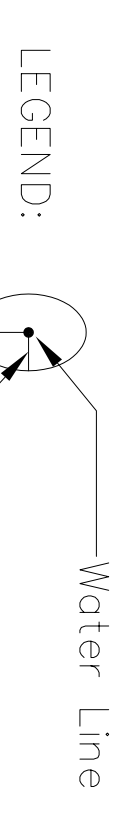

RECORD DOCUMENT

7/98

Plan and Profile
Lines 1.20 and 1.30

Florence Regional Sewer District
Florence, Indiana

JOB NO	193-2453	JCE	6/96
DWN BY	JCE		
CHK BY	JJG		
DATE	1/96		
SCALE	As Noted		

NO	DESCRIPTION	BY	DATE
1	REVISED LINE LOCATIONS	JCE	6/96

HOWARD J. BARTH & ASSOCIATES, INC.

CONSULTING ENGINEERS

347 E. WASHINGTON STREET
GREENSBURG, INDIANA 47240
812-663-2177 FAX 812/663-7906

