
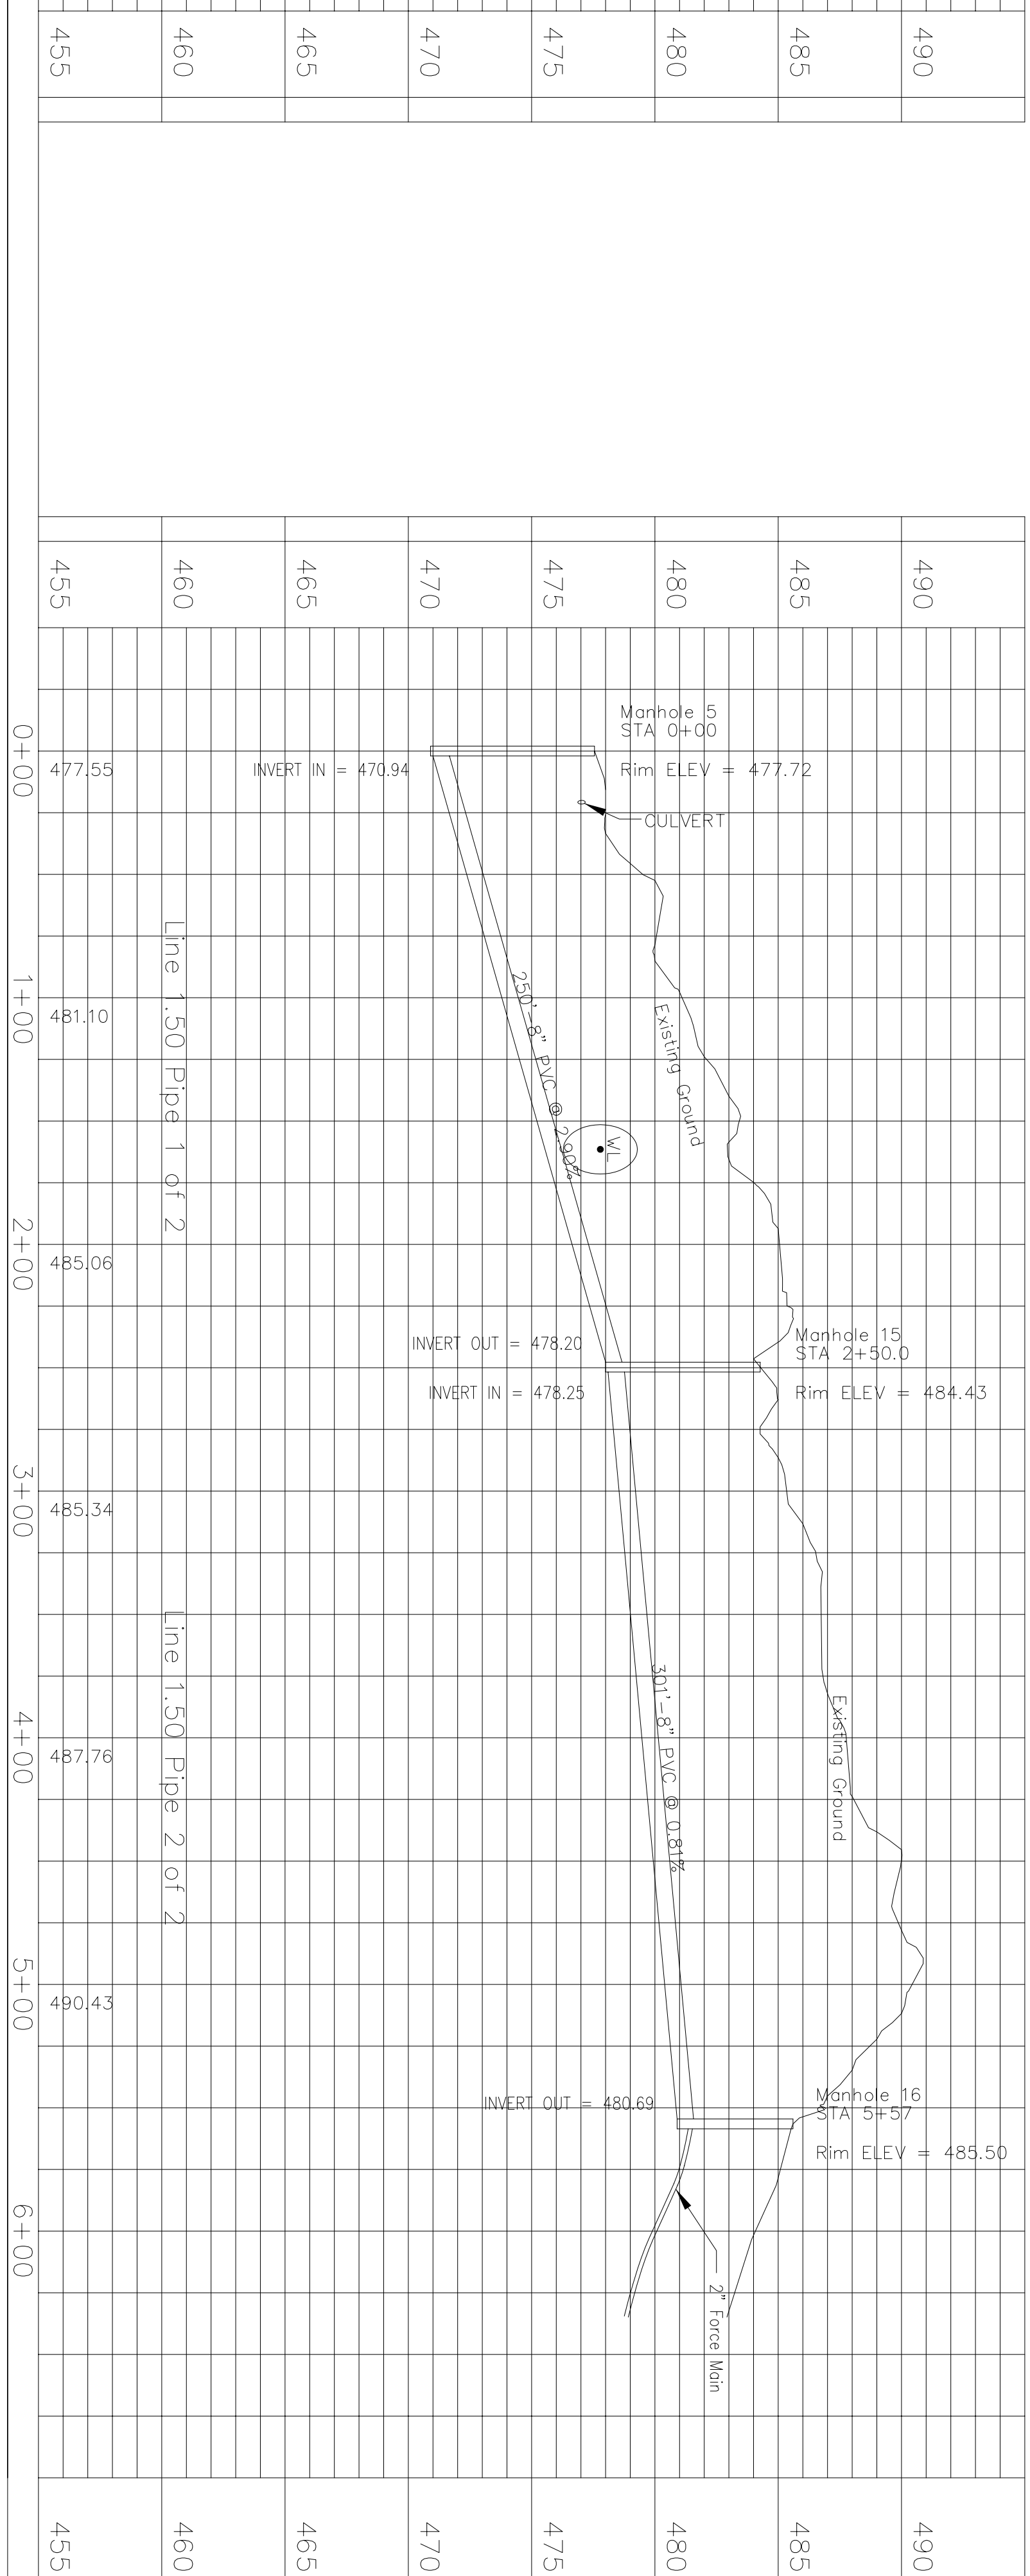



PLAN

SCALE: 1" = 50'

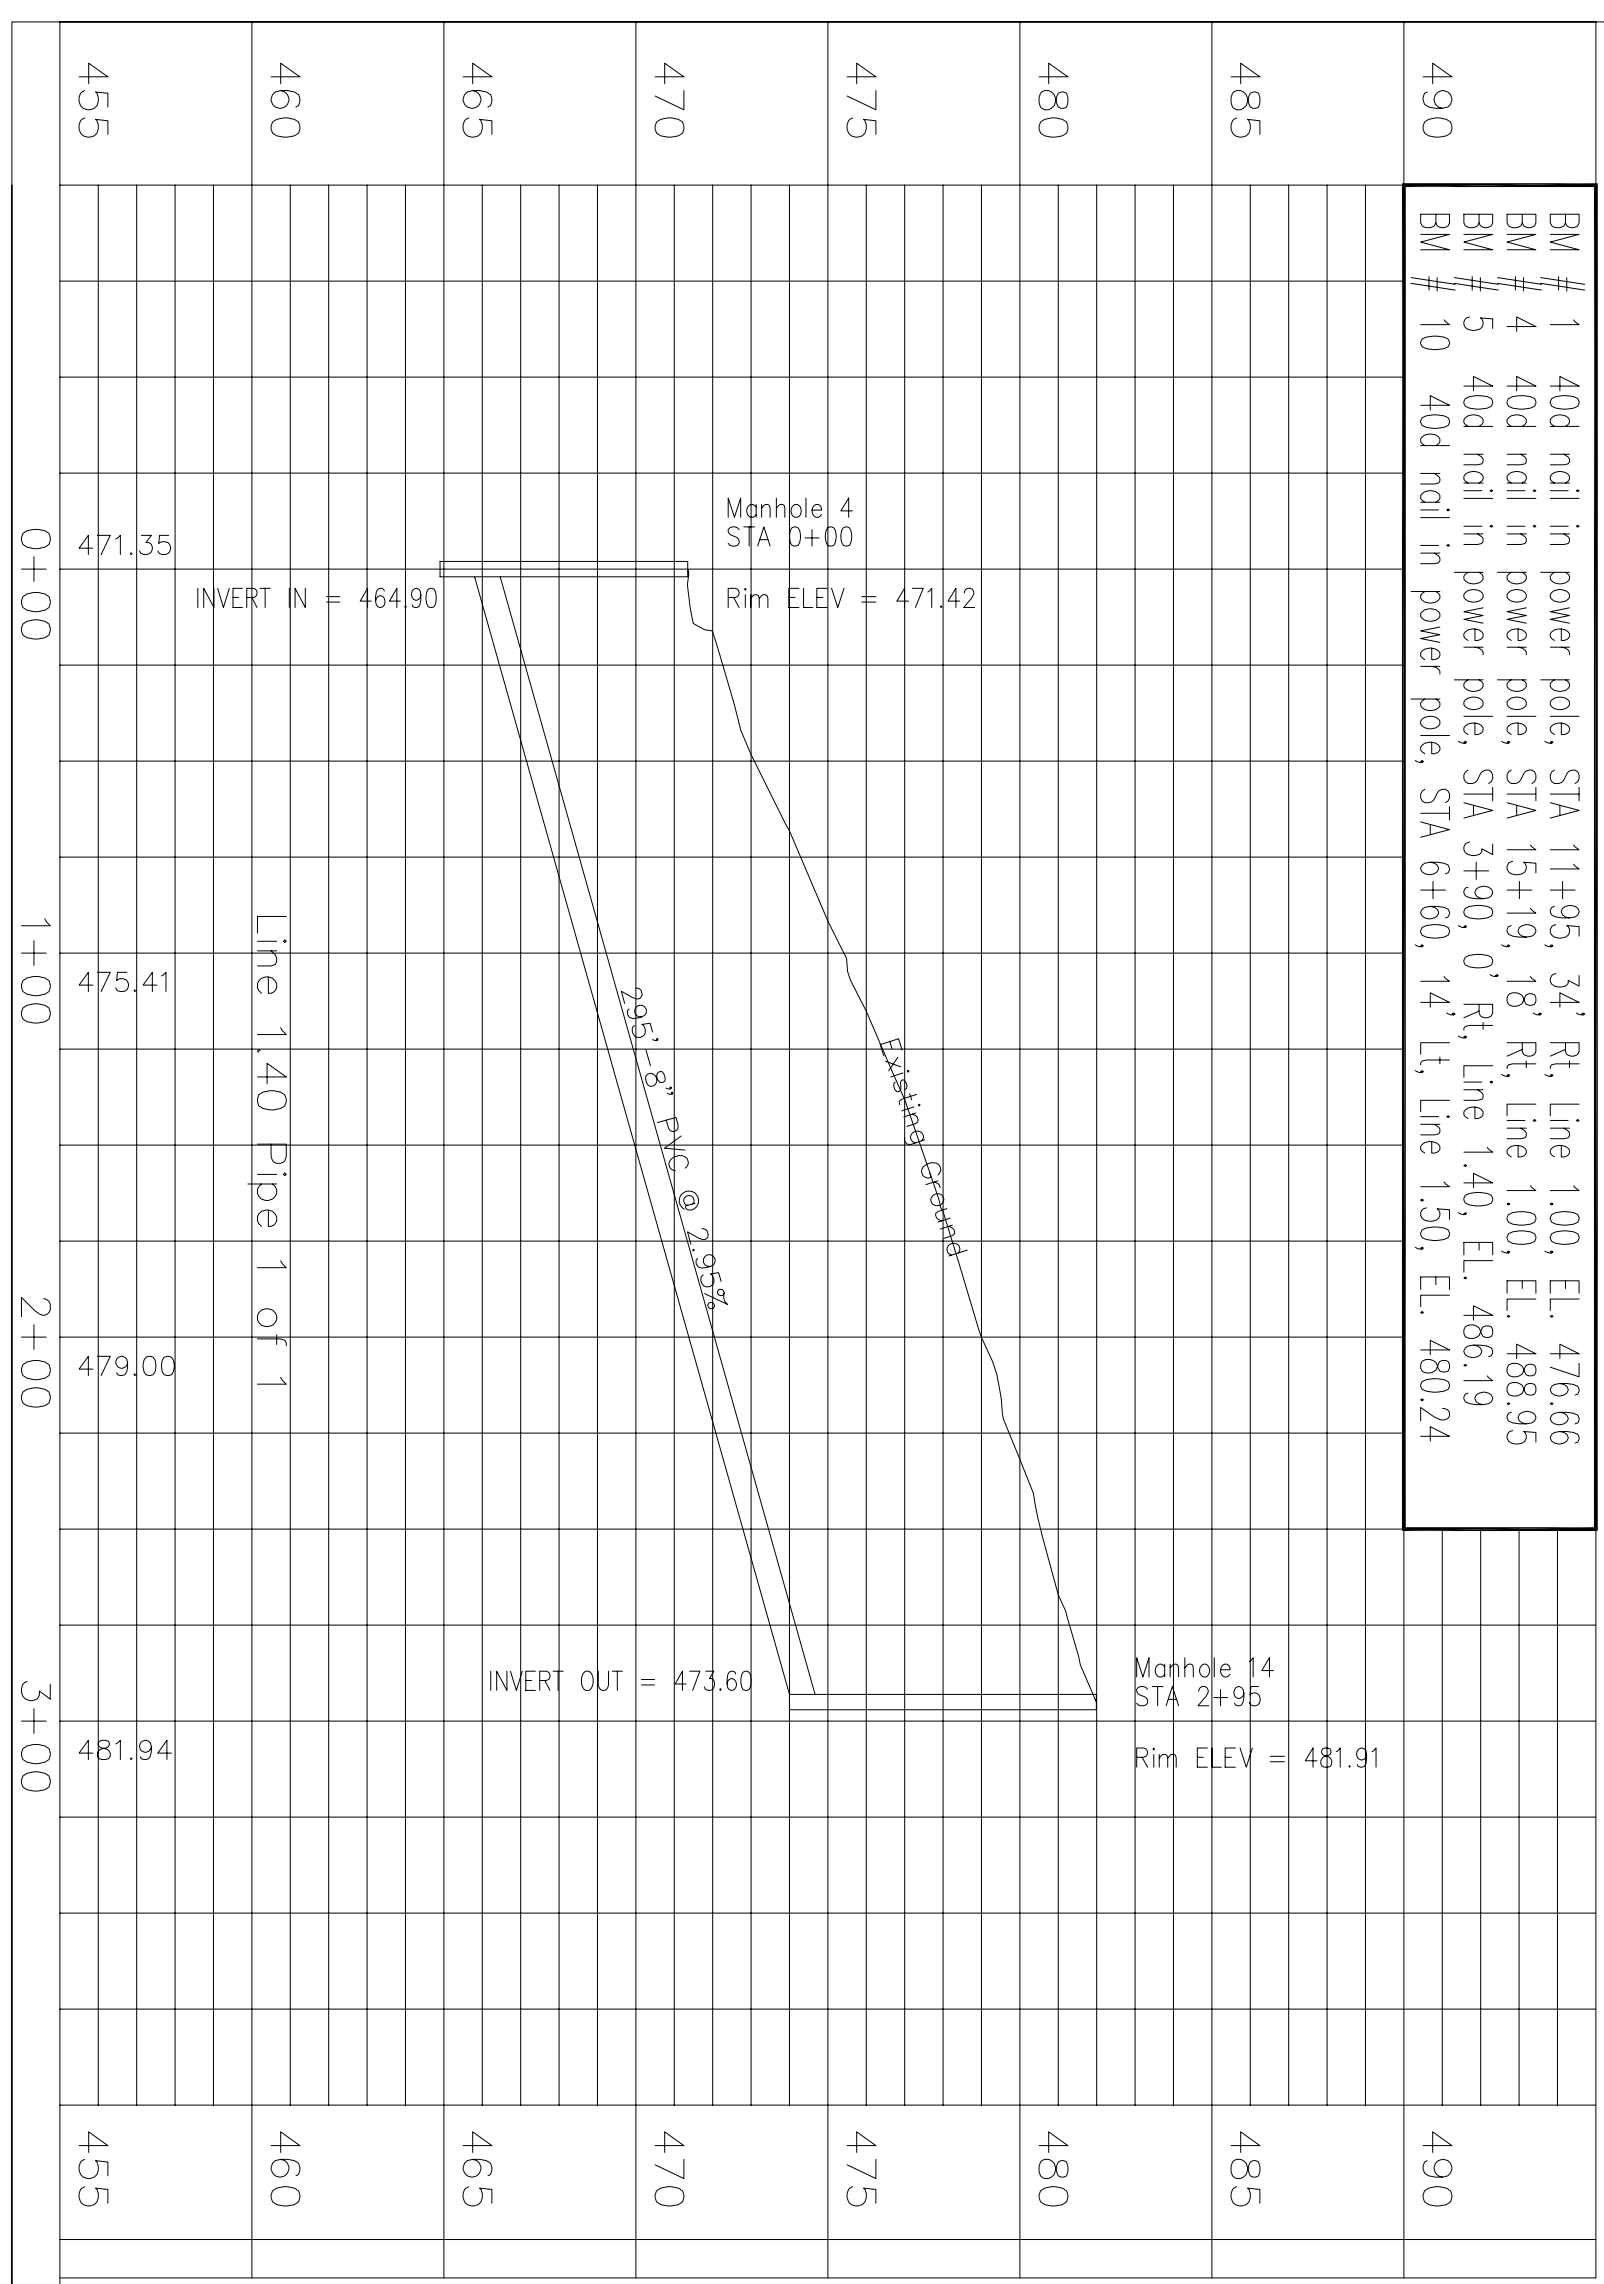

PROFILE

LEGEND:

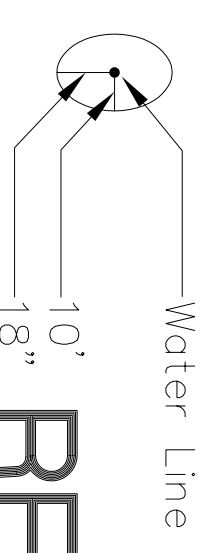

NOTES

1. ANY SEPTIC LEACH FIELD LINES CUT DURING CONSTRUCTION OF NEW SANITARY SEWER LINE SHALL BE RECONNECTED AT CONTRACTOR'S EXPENSE
2. ALL STREETS HAVE 60' RIGHT OF WAY UNLESS OTHERWISE NOTED
3. SOIL BORING INFORMATION IS AVAILABLE FOR REVIEW AT ENGINEER'S OFFICE

UTILITY NOTES

CONTRACTOR TO NOTIFY INDIANA UNDERGROUND PLANT PROTECTION CENTER ("HOLEY MOLEY") @ 1-800-382-5544, MINIMUM 2 WORKING DAYS PRIOR TO THE START OF CONSTRUCTION AND REQUEST ALL UNDERGROUND UTILITIES BE MARKED
 CALL ONLY ALERTS MEMBER UTILITIES, CONTRACTOR RESPONSIBLE FOR CONTACTING NON-MEMBER UTILITIES.

UTILITY COLOR CODES:

- RED - ELECTRIC
- YELLOW - GAS, OIL, PETROLEUM PRODUCTS
- GREEN - TELEPHONE
- ORANGE - FIBER OPTICS & TRAFFIC SIGNALS
- BLUE - WATER
- GREEN - SEWER
- WHITE - PROPOSED EXCAVATION

THE LOCATIONS OF UNDERGROUND UTILITIES AS SHOWN HEREIN HAVE BEEN OBTAINED FROM AVAILABLE RECORDS AND FIELD SURVEY. NEITHER THE OWNER NOR ENGINEER ASSUME RESPONSIBILITY FOR THE ACCURACY OF INFORMATION PROVIDED BY OTHERS
 SEE APPENDIX OF SPECIFICATIONS FOR STANDARD DETAILS
 SANITARY SEWER LINES TO BE LOCATED NO CLOSER THAN 10 FEET HORIZONTAL AND 1.5 FEET VERTICAL FROM WATER LINES.

SCALE: Ver 1" = 5' Horiz 1" = 50'

RECORD DOCUMENT


7/98

Plan and Profile
 Lines 1.40 and 1.50
 Florence Regional Sewer District
 Florence, Indiana

JOB NO	89-2453
DWN BY	JCE
CHK BY	JJG
DATE	1/96
SCALE	As Noted

NO	DESCRIPTION	BY	DATE
1	REVISED LINE LOCATIONS	JCE	6/96

HOWARD J. BARTH & ASSOCIATES, INC.
CONSULTING ENGINEERS
 347 E. WASHINGTON STREET
 GREENSBURG, INDIANA 47240
 812-663-2177 FAX 812/663-7906

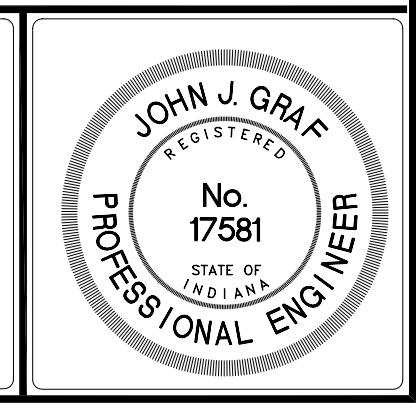

SHEET NUMBER
6